


## STANDARD 8' x 18' DOUBLE AXLE FOOD TRAILER

For custom plans, please contact Heekin Architectural LLC  
 ray.heekin@gmail.com / (617) 642-6178

**Oregon Food Trucks**


oregonfoodtrucks.com

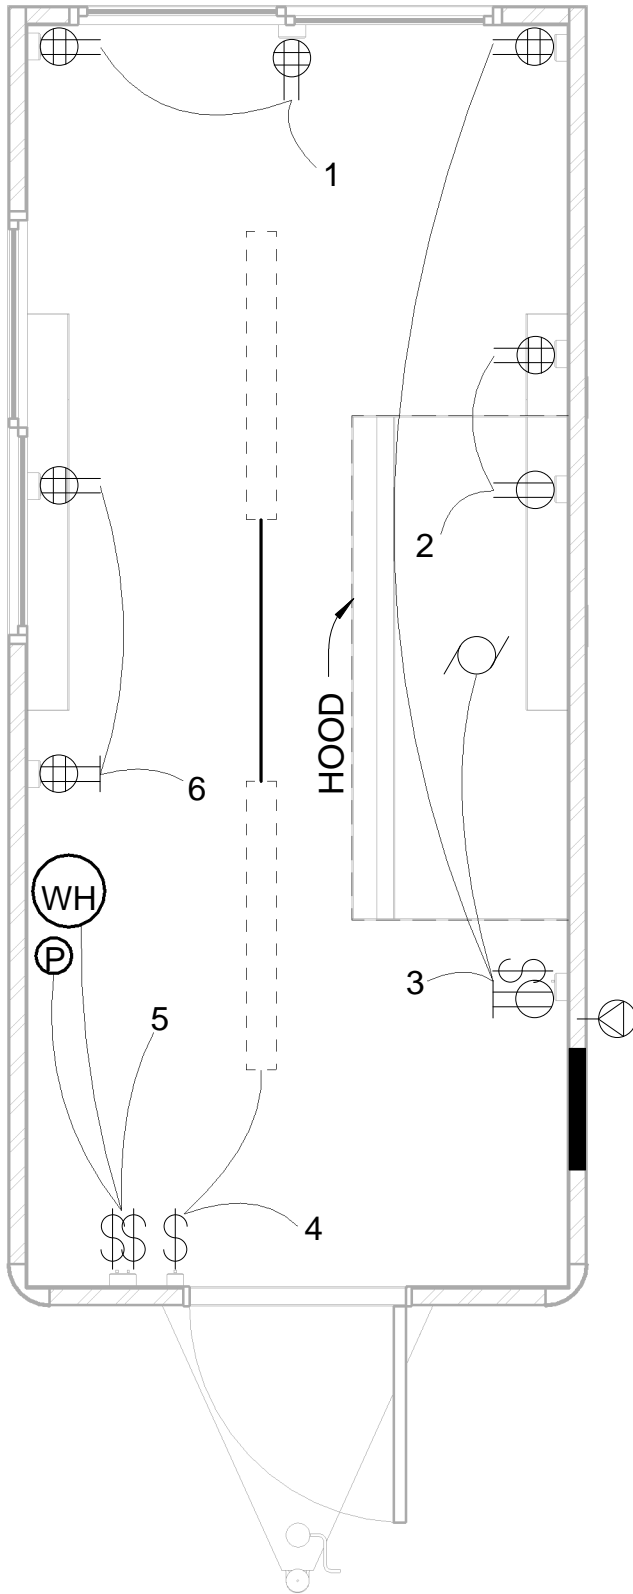

ELECTRICAL LEGEND	
	QUADRUPLEX GFI OUTLET
	QUADRUPLEX OUTLET
	DUPLEX GFI OUTLET
	DUPLEX OUTLET
	50A INLET
	SWITCH
	125A PANEL
WH	WATER HEATER
	WATER PUMP
	FAN
	FLUORESCENT LIGHT
	12 GAGE RIGID METAL CONDUIT MOUNTED TO INSIDE FACE OF TRAILER WALL
1	CIRCUIT SPACE NUMBER

**ELECTRICAL FLOOR PLAN**  
**STANDARD 8' x 18' DOUBLE AXLE FOOD TRAILER**  
 SCALE: 3/8" = 1' - 0"

For custom plans, please contact Heekin Architectural LLC  
 ray.heekin@gmail.com / (617) 642-6178

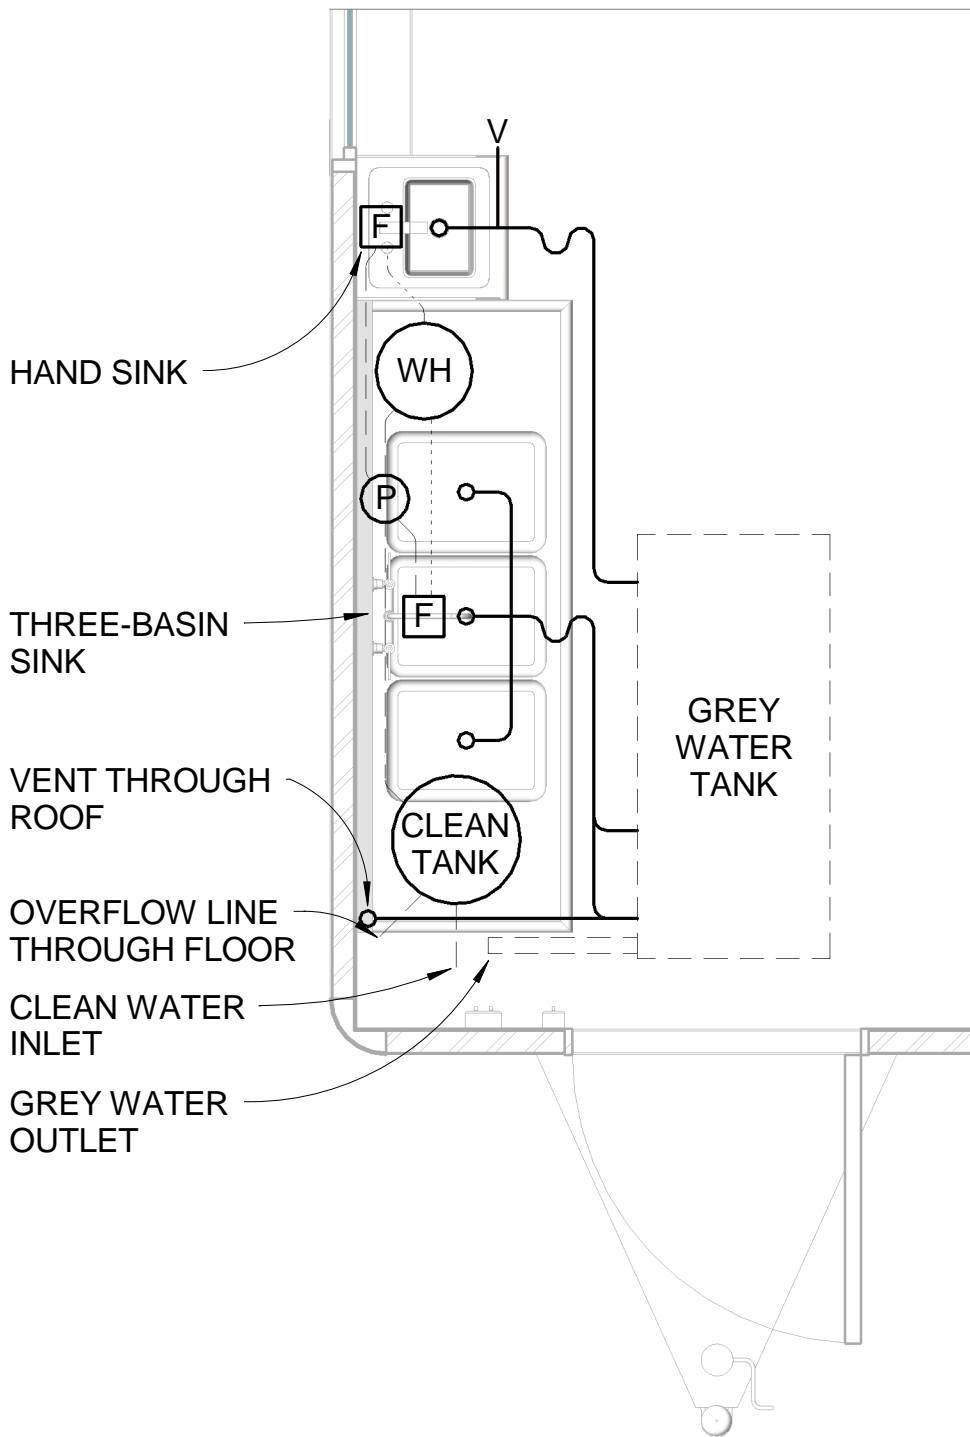

PLUMBING LEGEND	
Ⓟ	WATER PUMP
WH	WATER HEATER
Ⓛ	FAUCET
V	ABS IN-LINE VENT
---	COLD WATER
⋯	HOT WATER
—	GREY WATER

ALL POTABLE WATER LINES ARE 3/4" BRAIDED RUBBER HOISING

GREY WATER LINES ARE 2" PVC

GREY WATER DRAIN PIPE IS 2" PVC

DISTANCE FROM WATER PUMP TO FURTHEST PLUMBING FIXTURE: 2' - 0"

**PLUMBING FLOOR PLAN**  
**STANDARD 8' x 18' DOUBLE AXLE FOOD TRAILER**  
 SCALE: 1/2" = 1' - 0"

For custom plans, please contact Heekin Architectural LLC  
 ray.heekin@gmail.com / (617) 642-6178

**Oregon Food Trucks**  
 oregonfoodtrucks.com